

TOWN OF MARION, MASSACHUSETTS

WATER WORKS IMPROVEMENTS

WATER TREATMENT CHEMICAL FEED FACILITIES

BOARD OF SELECTMEN

EDWIN H. B. PRATT, CHAIRMAN
JOHN W. HOAGLAND
LORETTA B. SCHAEFER


EXECUTIVE SECRETARY

RAY E. PICKLES

SUPERINTENDENT OF PUBLIC WORKS

ROBERT C. ZORA

FEBRUARY, 1989

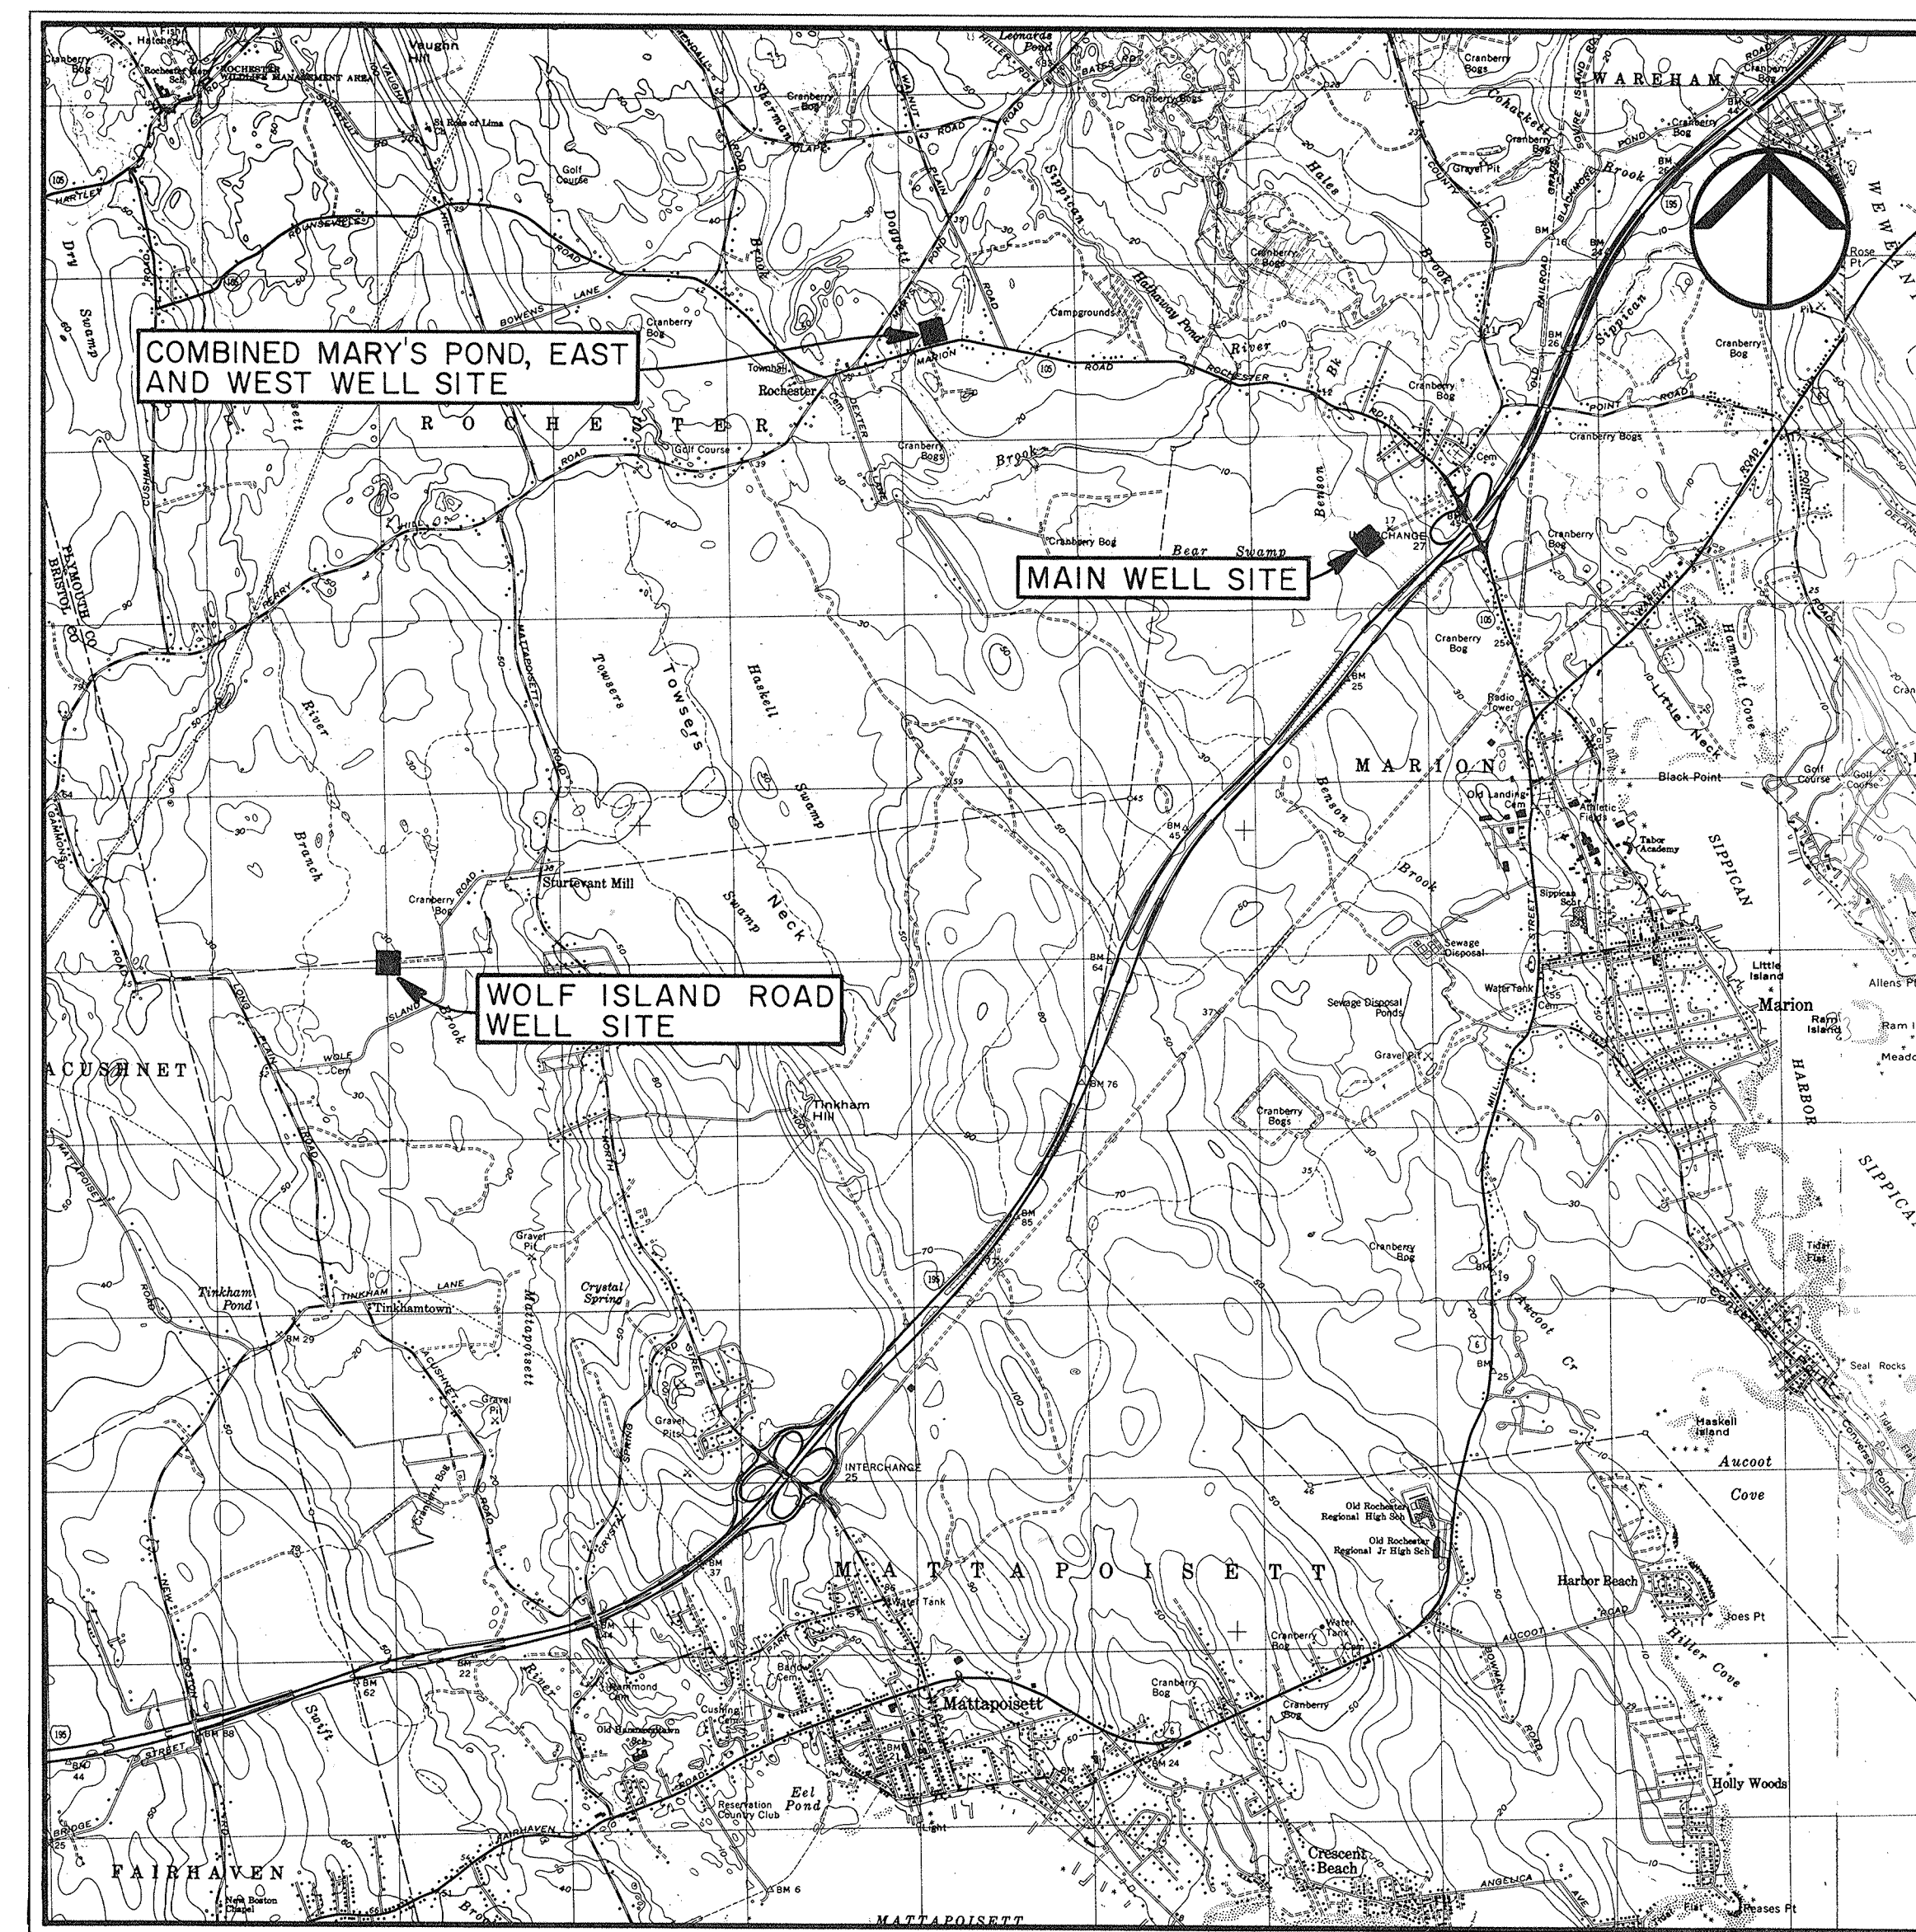

2000 1000 0 2000 4000 6000
SCALE IN FEET

LOCATION PLAN

LIST OF DRAWINGS

<u>SHEET NO.</u>	<u>TITLE</u>
1.	COMBINED STATION SITE PLAN AND YARD PIPING PLAN
2.	MAIN STATION SITE PLAN AND YARD PIPING PLAN AND MISCELLANEOUS DETAILS
3.	WOLF ISLAND ROAD SITE PLAN AND YARD PIPING PLAN AND MISCELLANEOUS DETAILS
4.	CHEMICAL FEED PLAN, SECTIONS AND DETAILS I
5.	CHEMICAL FEED PLAN, SECTIONS AND DETAILS II
6.	MAIN STATION ARCHITECTURAL AND HEATING AND VENTILATION
7.	ELECTRICAL SITE PLANS
8.	ELECTRICAL POWER AND LIGHTING PLANS
9.	ELECTRICAL SYMBOL LIST AND PANEL SCHEDULE
10.	ELECTRICAL ONE LINE DIAGRAMS

