

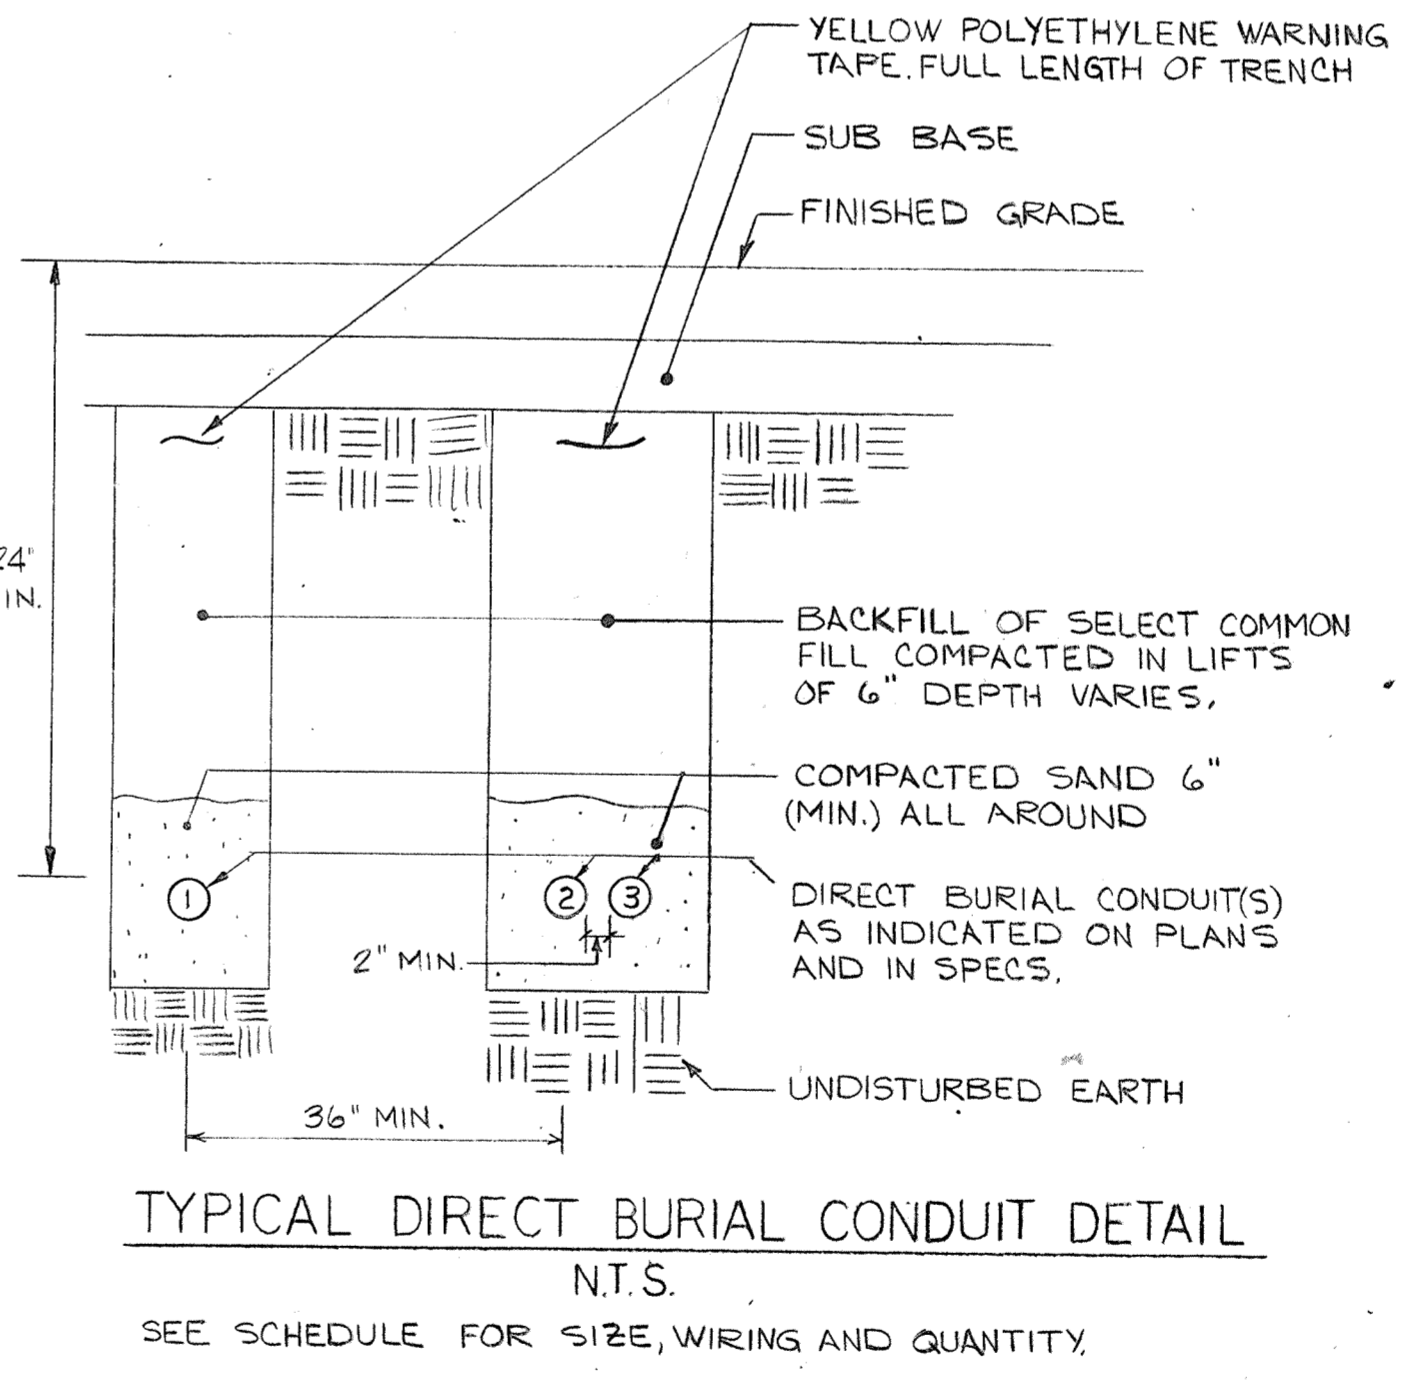
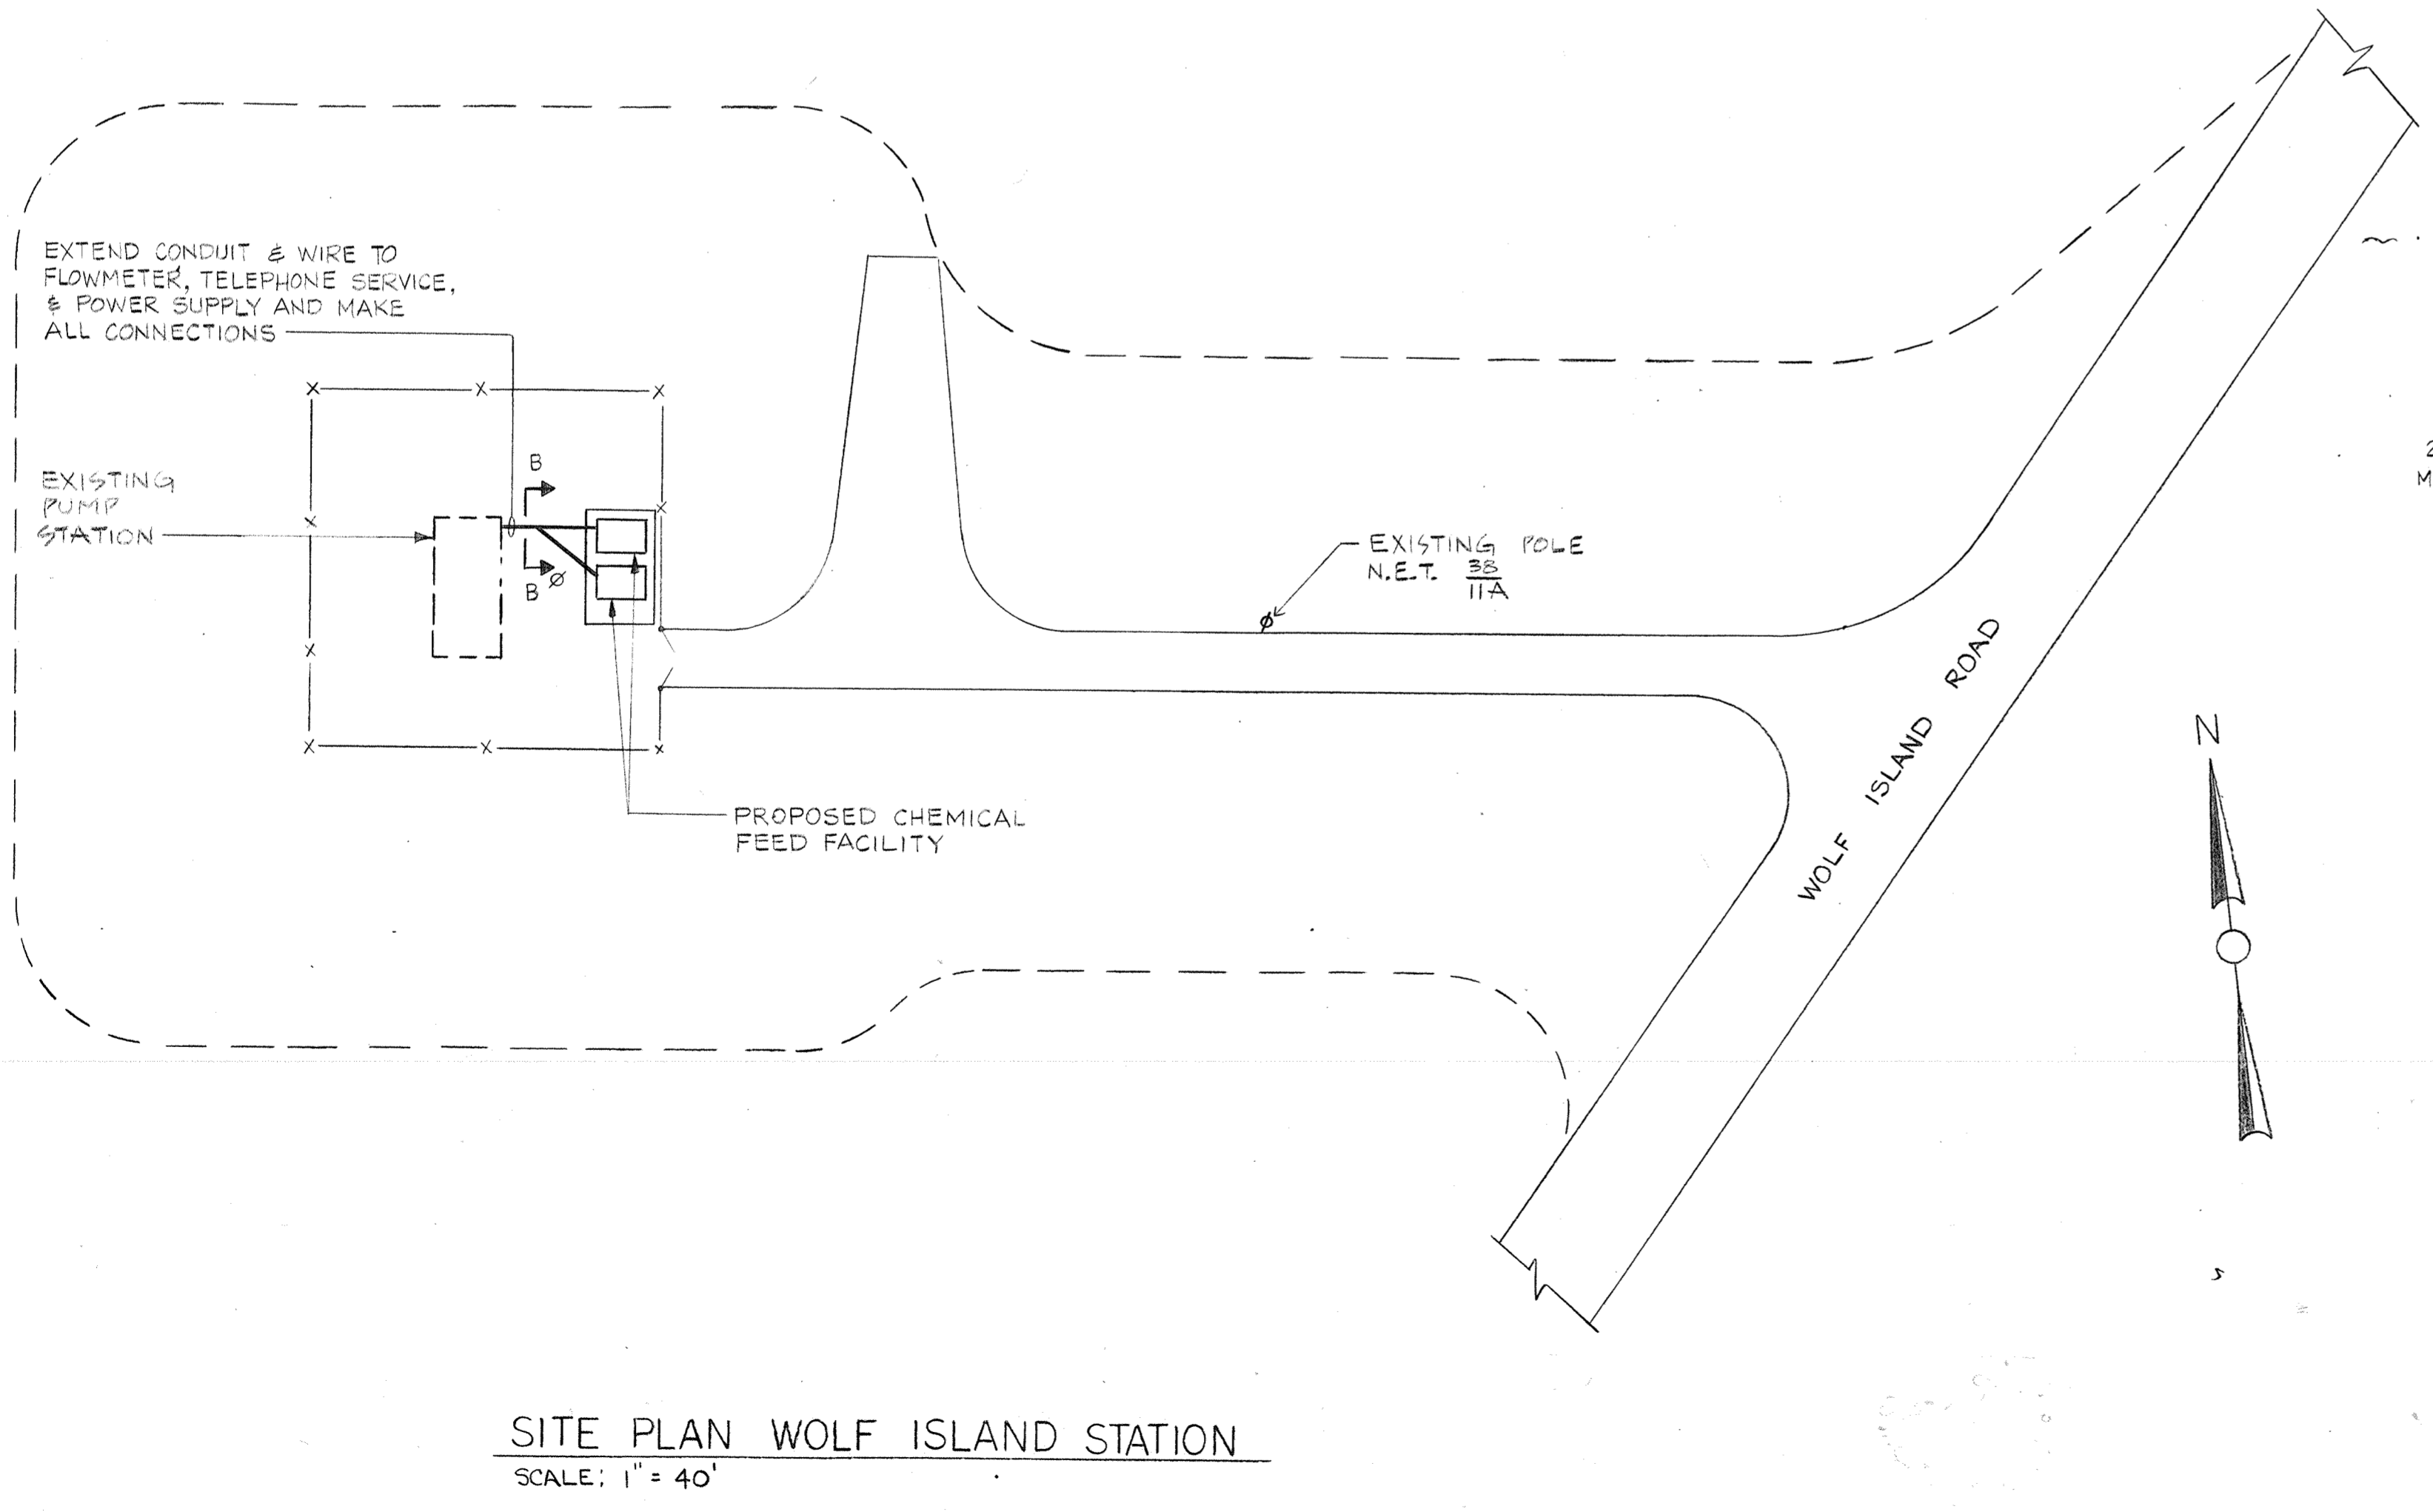


NOTES:
 1. SEE SHEET E-4 FOR "ONE LINE DIAGRAMS" AND SHEET E-2 FOR ADDITIONAL WIRING INFORMATION.

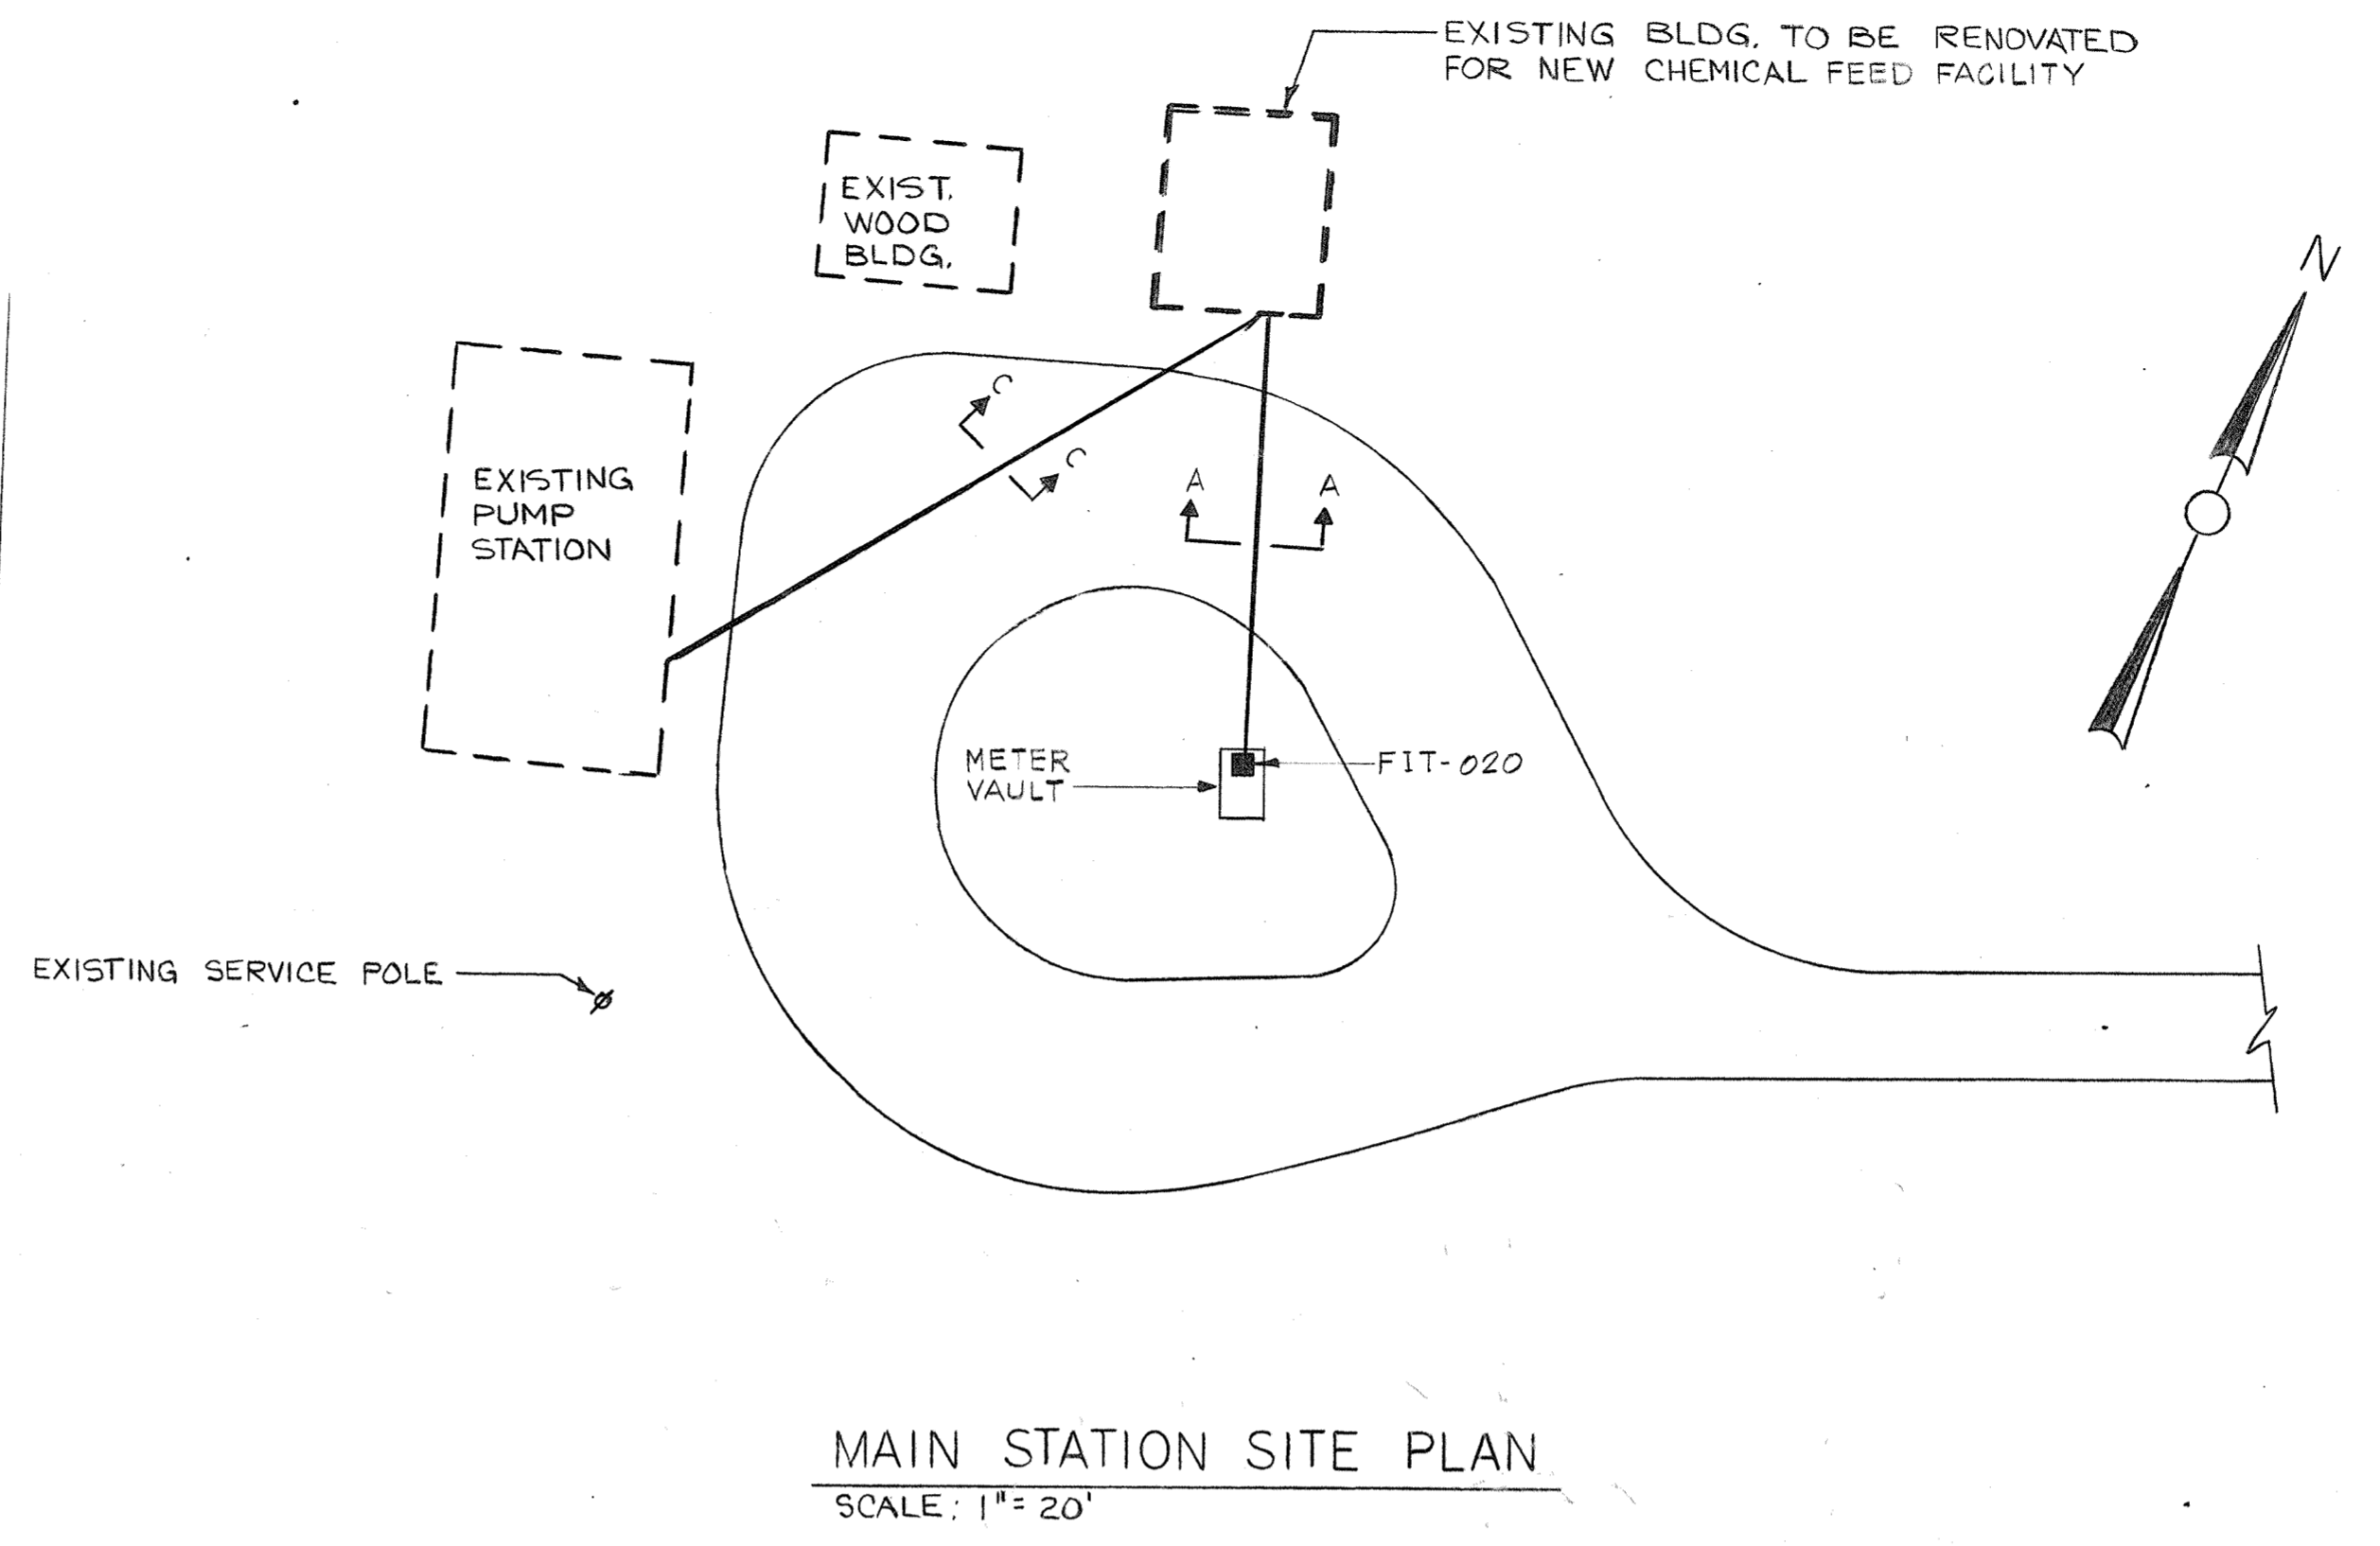

UNDERGROUND DUCT SCHEDULE			
SECTION	DUCT SIZE AND WIRING		
	1	2	3
A-A	2/c#16TS, 1" C.	—	—
B-B	4 #10, 1" C.	1" C. (TEL.)	2/c#16TS, 1" C. (FIT-001)
C-C	3 #6, 1 1/4" C.	2/c#16, 1" C. (TEL.)	—
D-D	3 #2, 1 1/2" C.	1 1/2" C. (TEL.)	—

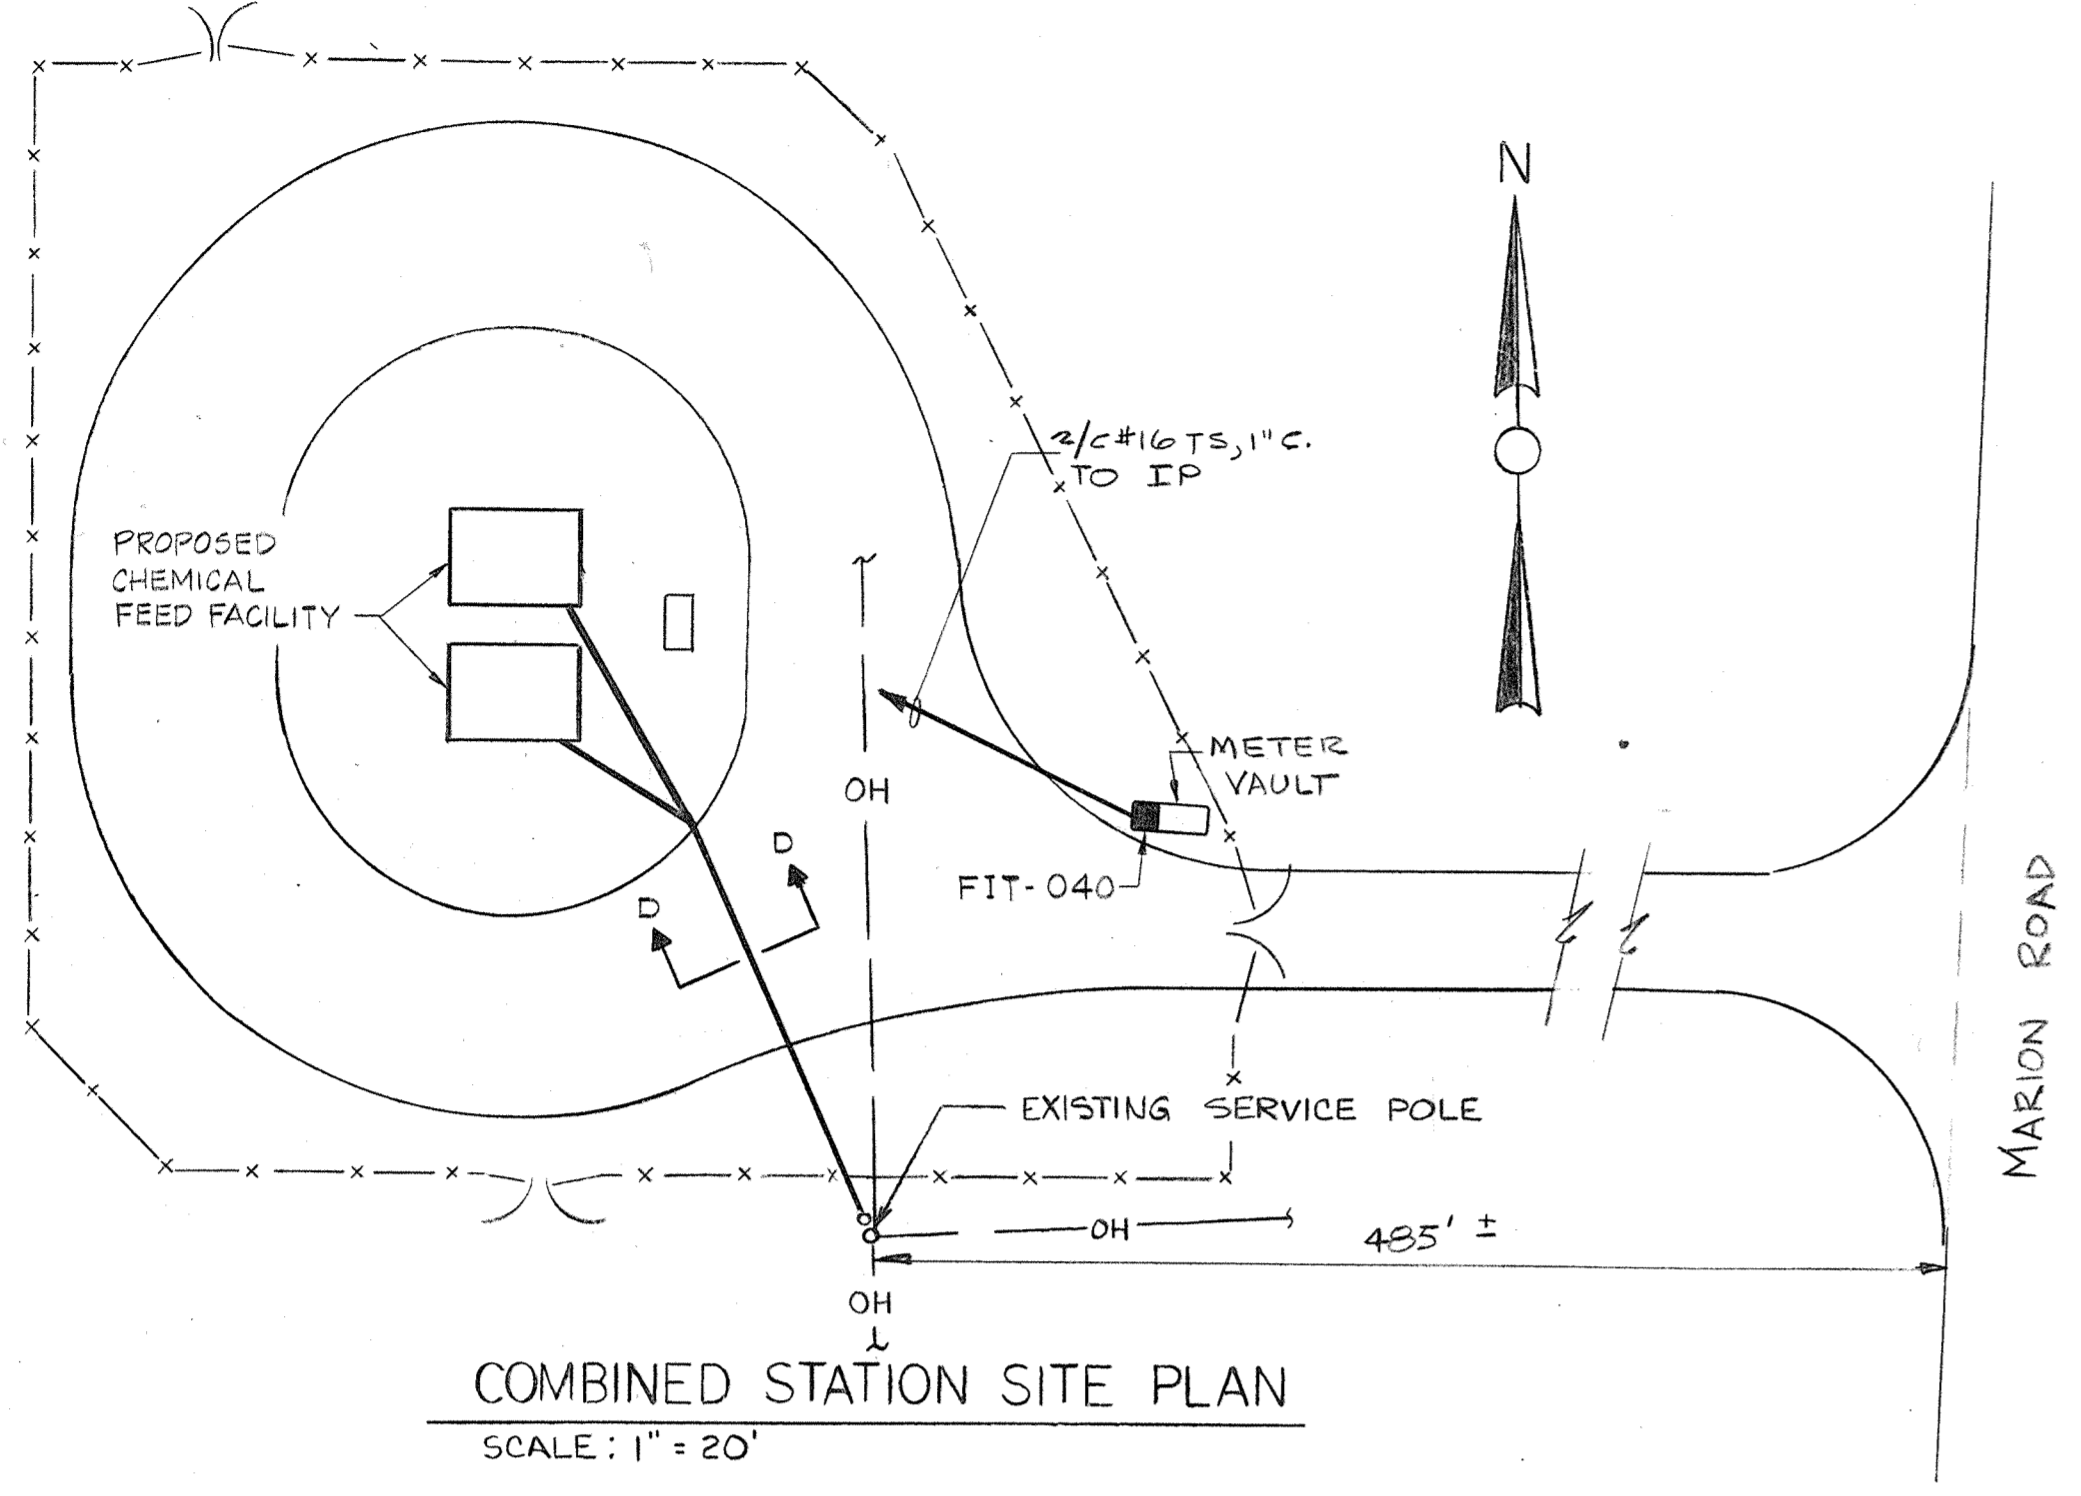

Date	Ch'k'd.	Revision
12-21-88	CPK	1
	DH	
	JK	
	JK	

TOWN OF MARION MASSACHUSETTS	
WATER WORKS IMPROVEMENTS	
CHEMICAL FEED FACILITIES	
ELECTRICAL SITE PLANS	
CAMP DRESSER & MCKEE INC. One Center Plaza Boston, Massachusetts 02108 environmental engineers, scientists, planners, & management consultants	SHEET NO. 7 357-42456