

# TOWN OF MARION, MASSACHUSETTS

## WATER WORKS IMPROVEMENTS

# PRODUCTION WELL EQUIPMENT

### BOARD OF SELECTMEN

LORETTA B. SCHAEFER, CHAIRPERSON

EDWIN H. B. PRATT


JAMES S. DOUGALL

### EXECUTIVE SECRETARY

RAY E. PICKLES


### SUPERINTENDENT OF PUBLIC WORKS

ROBERT C. ZORA

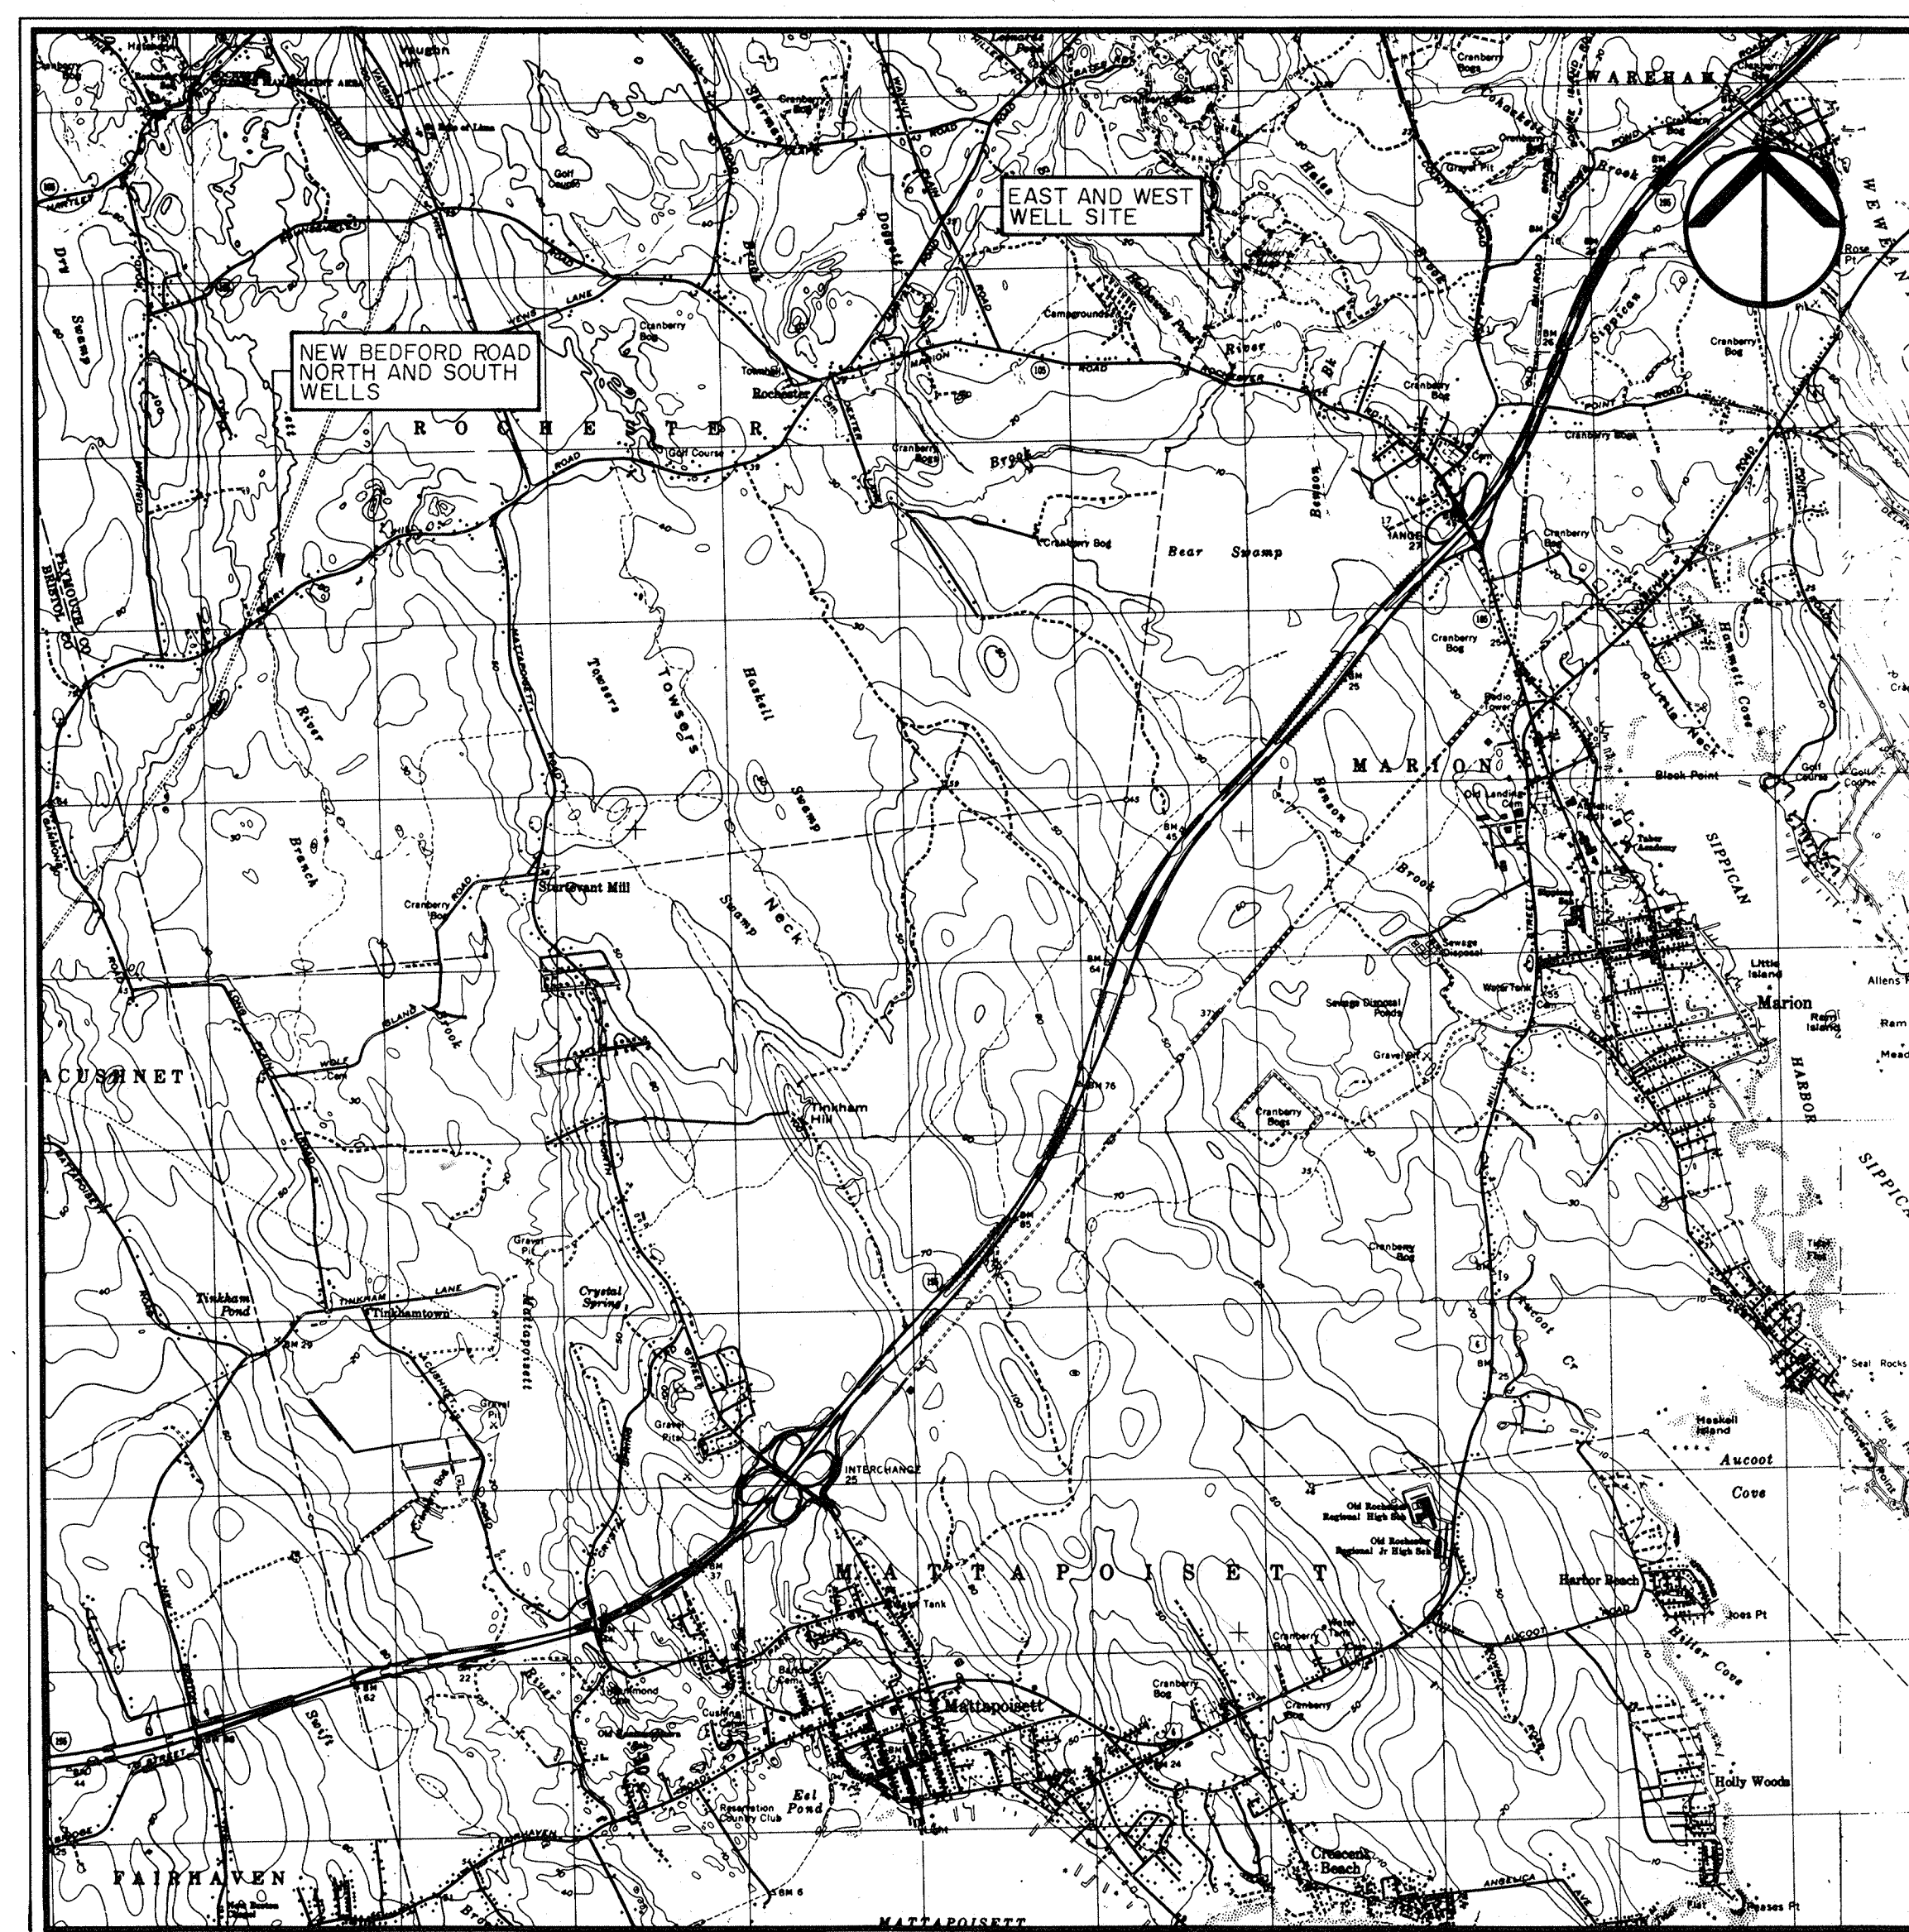

2000 1000 0 2000 4000 6000  
SCALE IN FEET

LOCATION PLAN

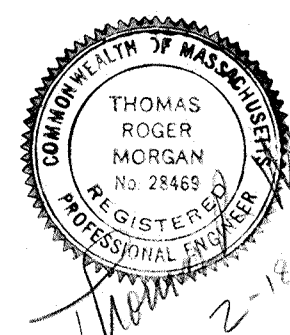

### LIST OF DRAWINGS

<u>SHEET NO.</u>	<u>TITLE</u>
1	WEST AND EAST WELL SITE WATER MAIN AND DETAILS
2	WEST AND EAST WELL SITE PLANS AND DETAILS
3	WEST WELL BUILDING RENOVATION PLANS AND SECTION
4	NEW BEDFORD ROAD WELLS SITE PLAN
5	WELL DETAILS
6	MISCELLANEOUS DETAILS
7	ELECTRICAL SYMBOL LIST
8	SINGLE LINE DIAGRAM AND PANELBOARD SCHEDULE
9	WEST AND EAST WELL ELECTRICAL SITE PLAN AND DETAILS
10	WEST AND EAST WELL BUILDING POWER AND LIGHTING PLANS

JANUARY 1993